




COPYRIGHT © 2022. THESE DRAWINGS ARE INSTRUMENTS OF SERVICE ONLY AND REMAIN THE PROPERTY OF . REPRODUCTION, USE OR TRANSLATION THEREOF WITHOUT WRITTEN PERMISSION IS UNLAWFUL.

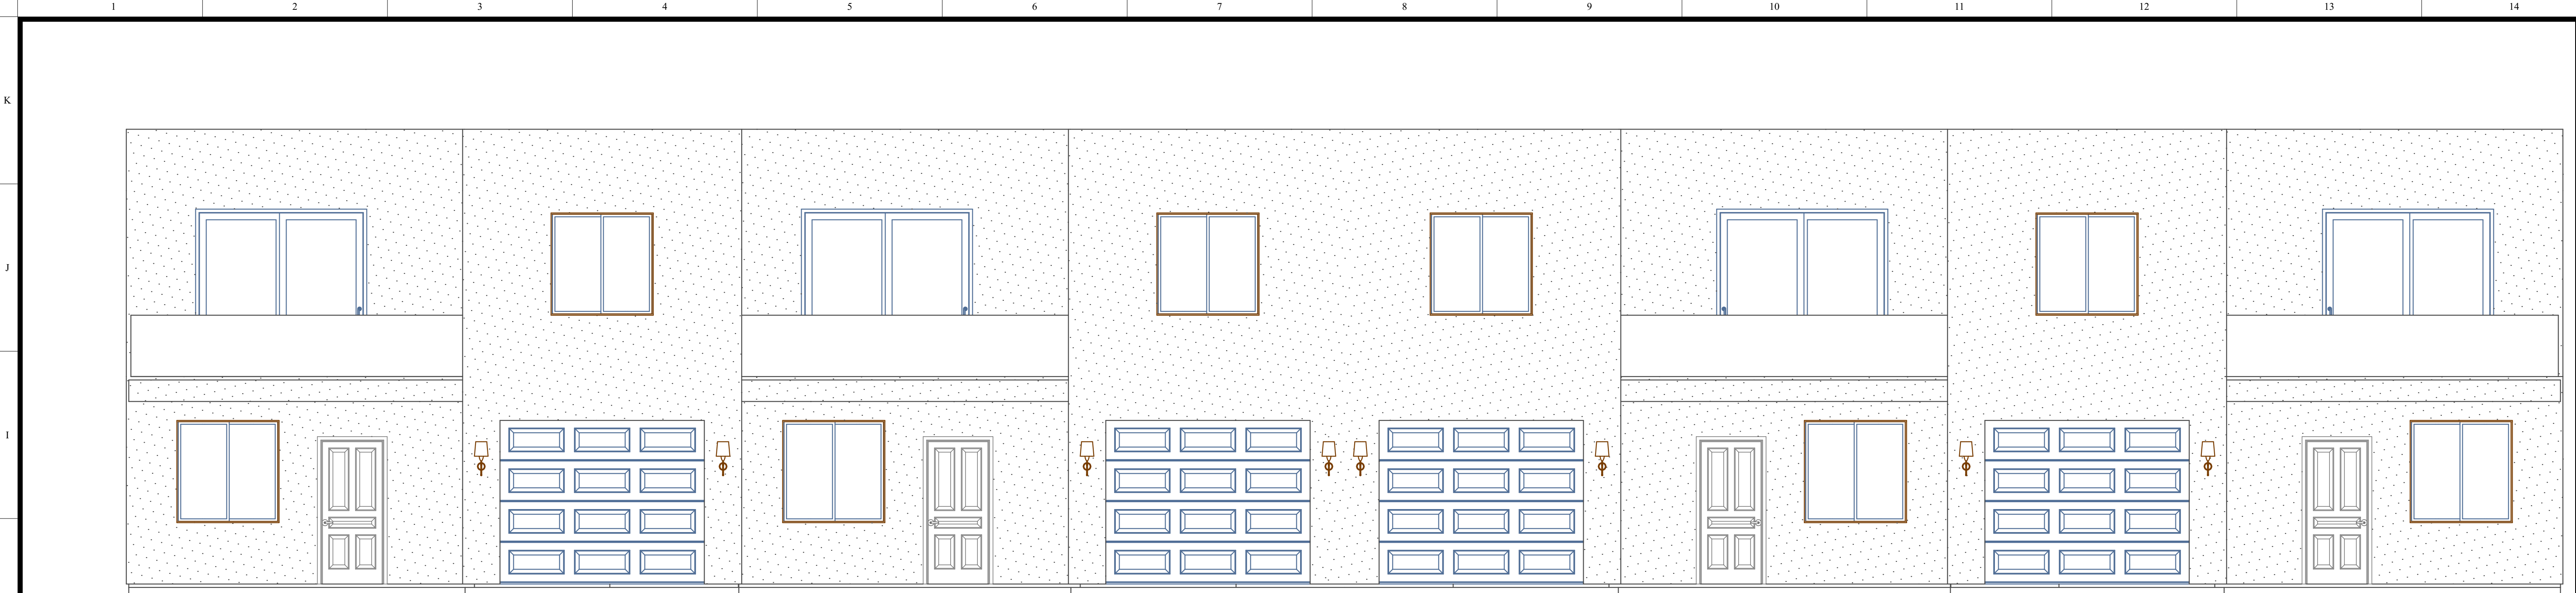


H1 Front Elevation
SCALE: 1/4" = 1'-0"

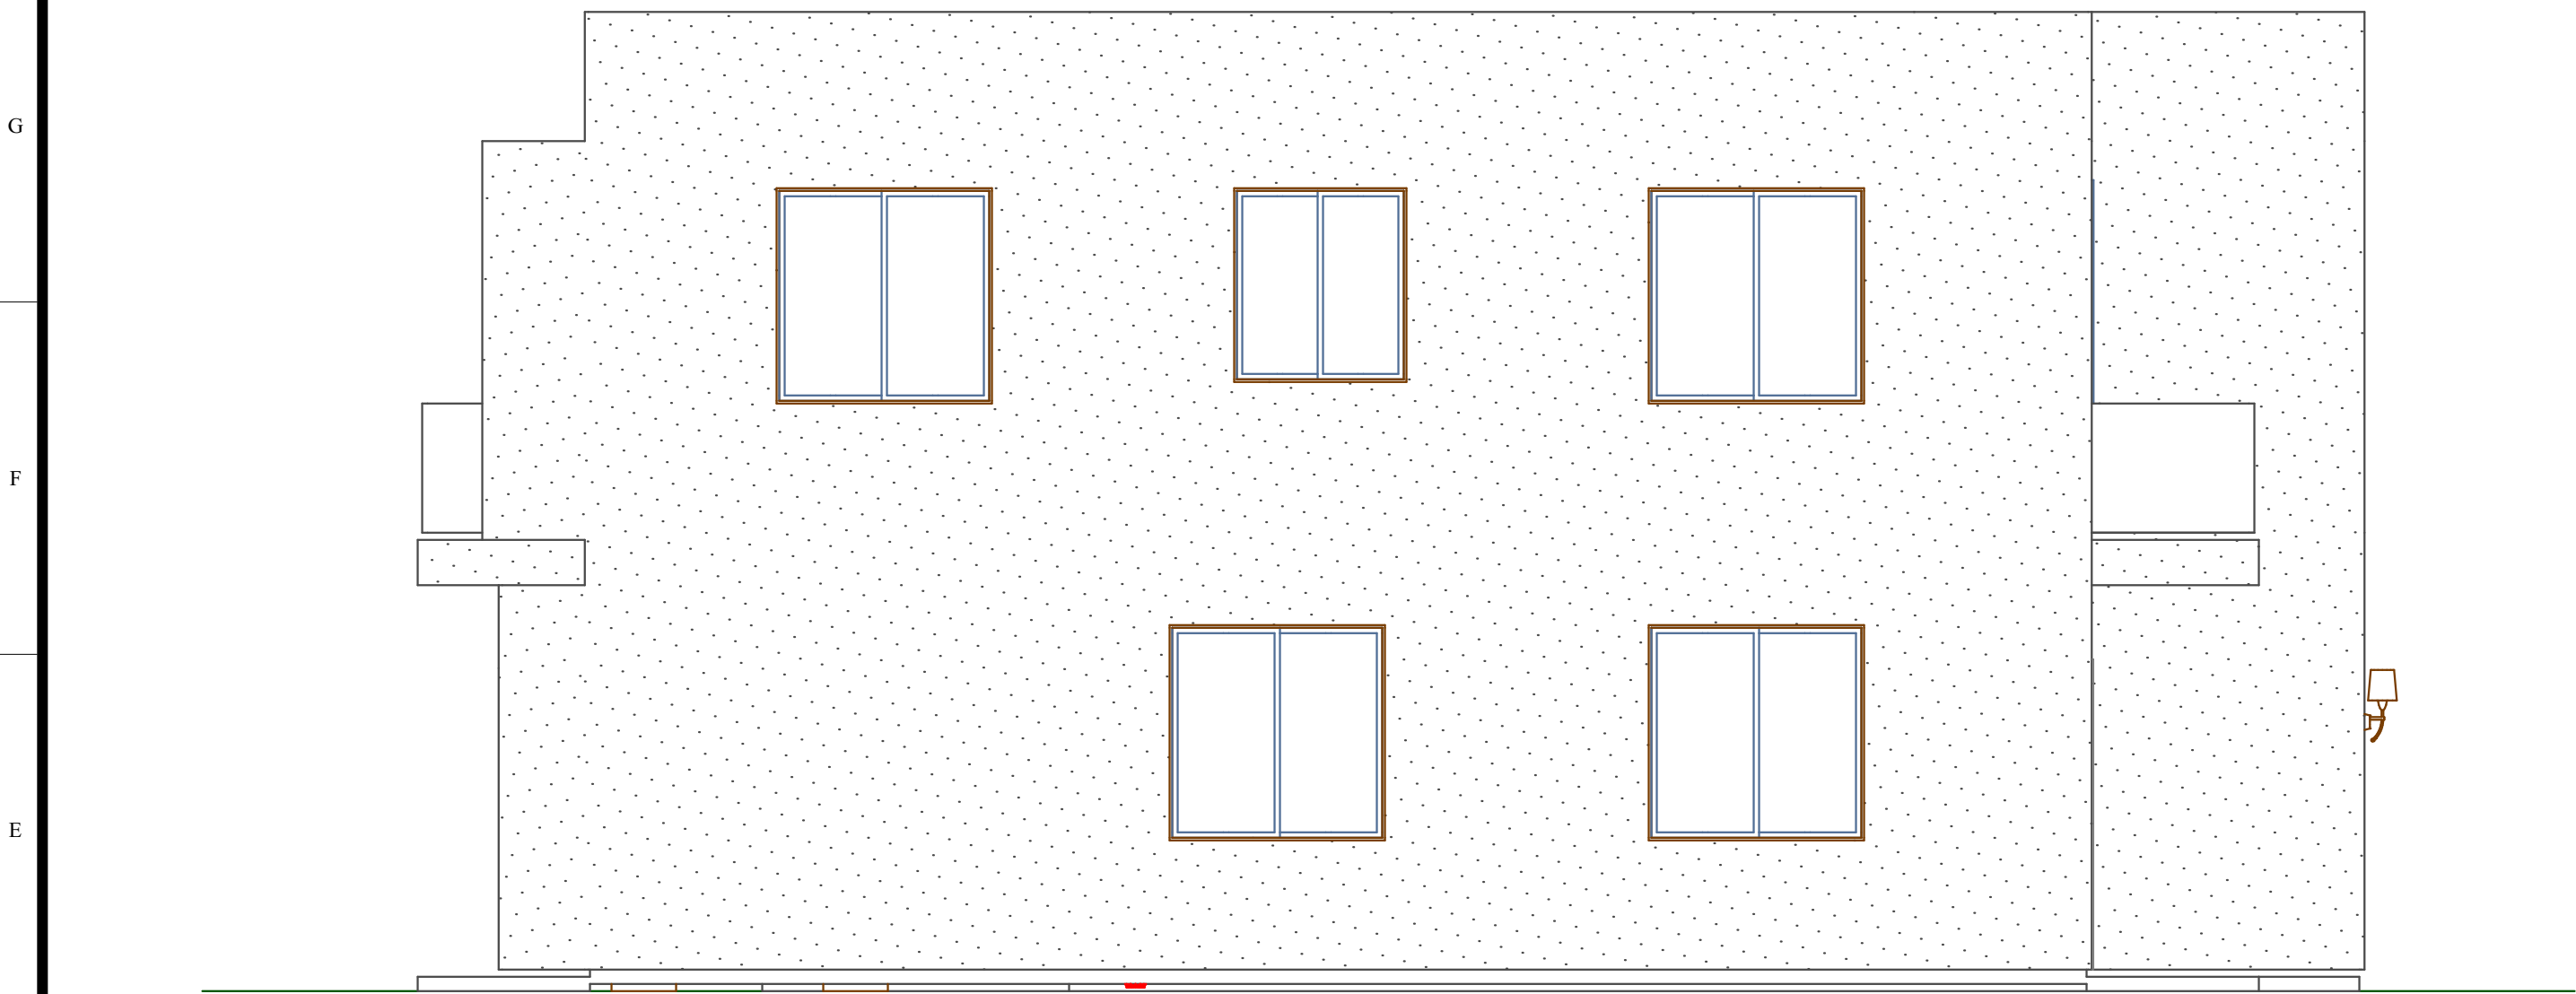

E1 Left Elevation
SCALE: 1/4" = 1'-0"

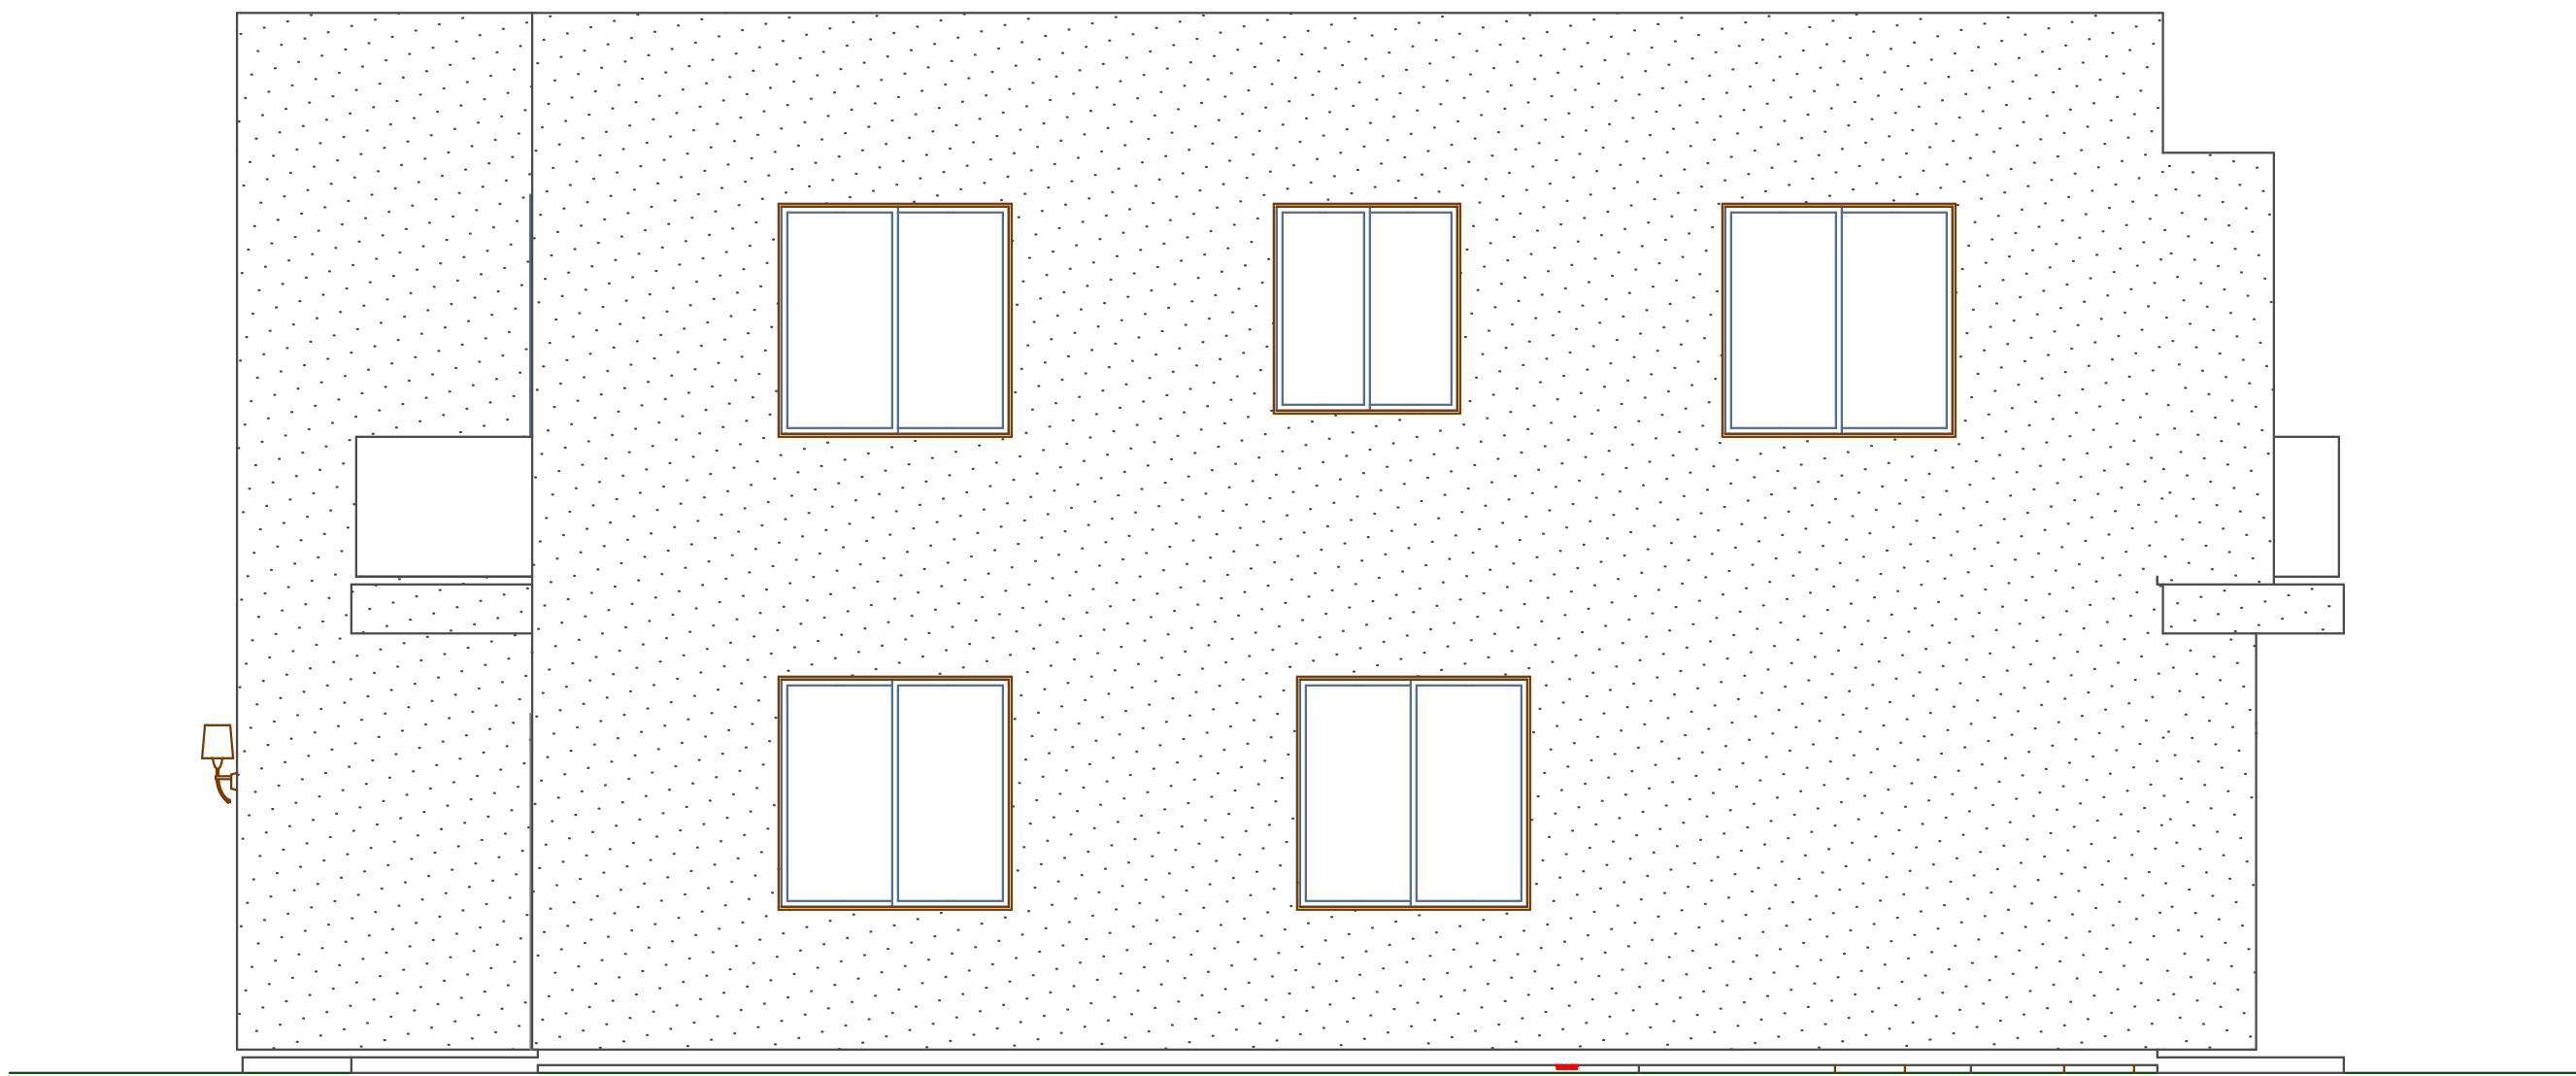

E8 Right Elevation
SCALE: 1/4" = 1'-0"

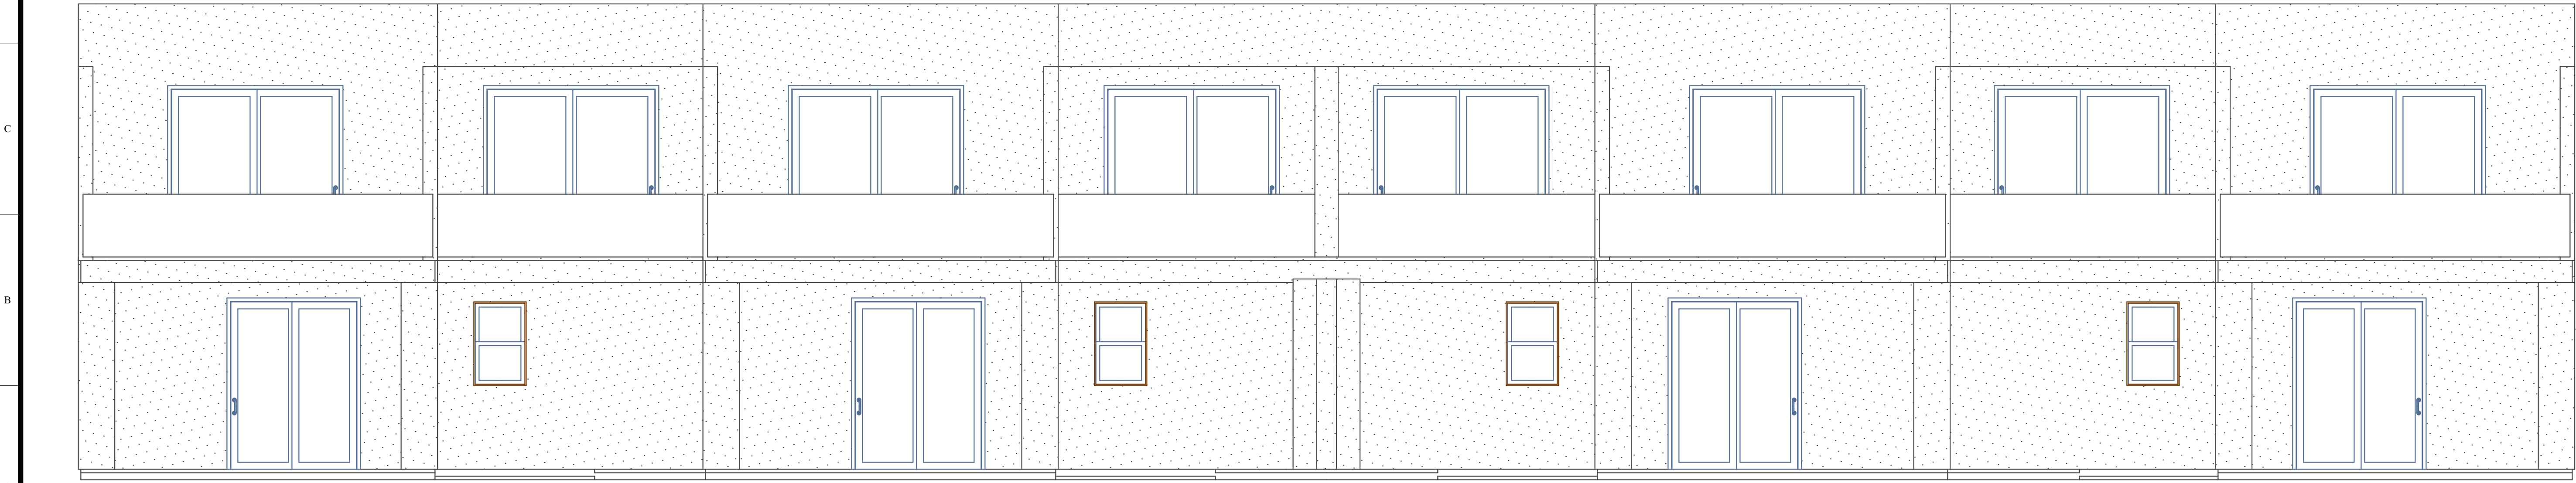

A1 Back Elevation
SCALE: 1/4" = 1'-0"

CLIENT: Big Water Townhomes

PROJECT:


Plan - Lake Powell, I


MARK	DATE	DESCRIPTION

DATE: 1/5/2022
DRAWN BY:
PROJECT #:
PLAN ID:

SHEET NAME:
Elevations

ph. (702) 346-1174 fx. (702) 346-4252

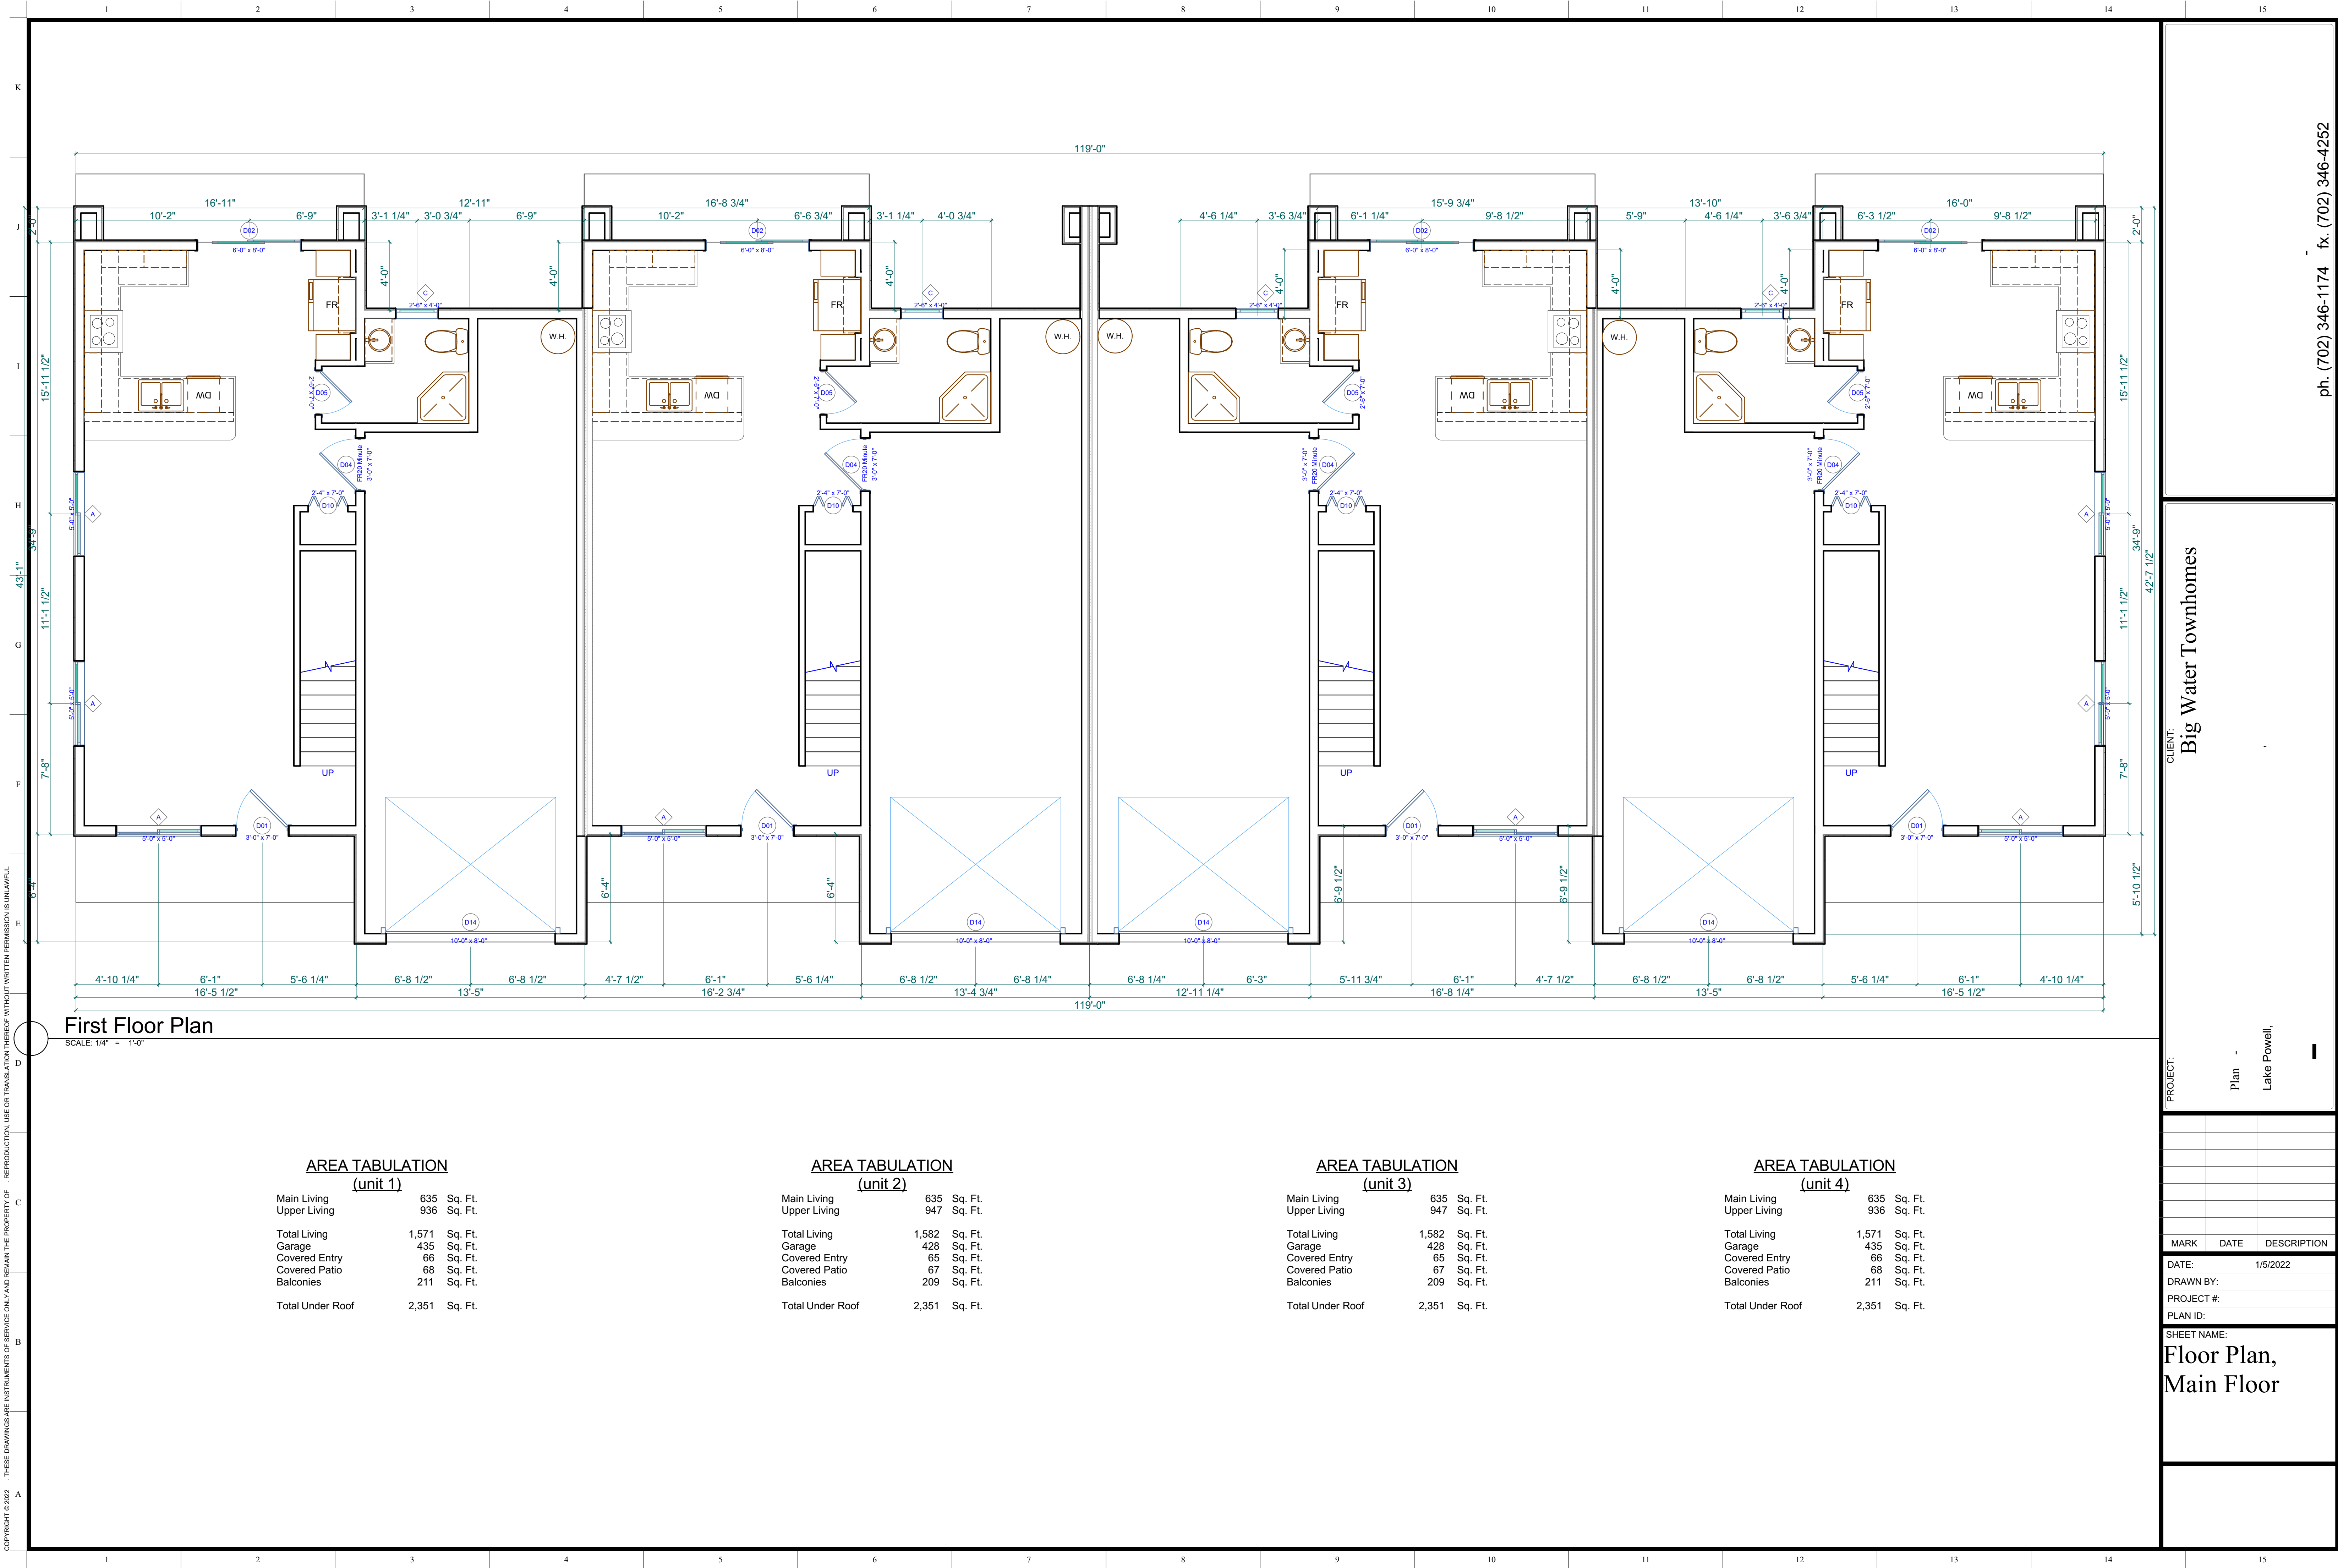

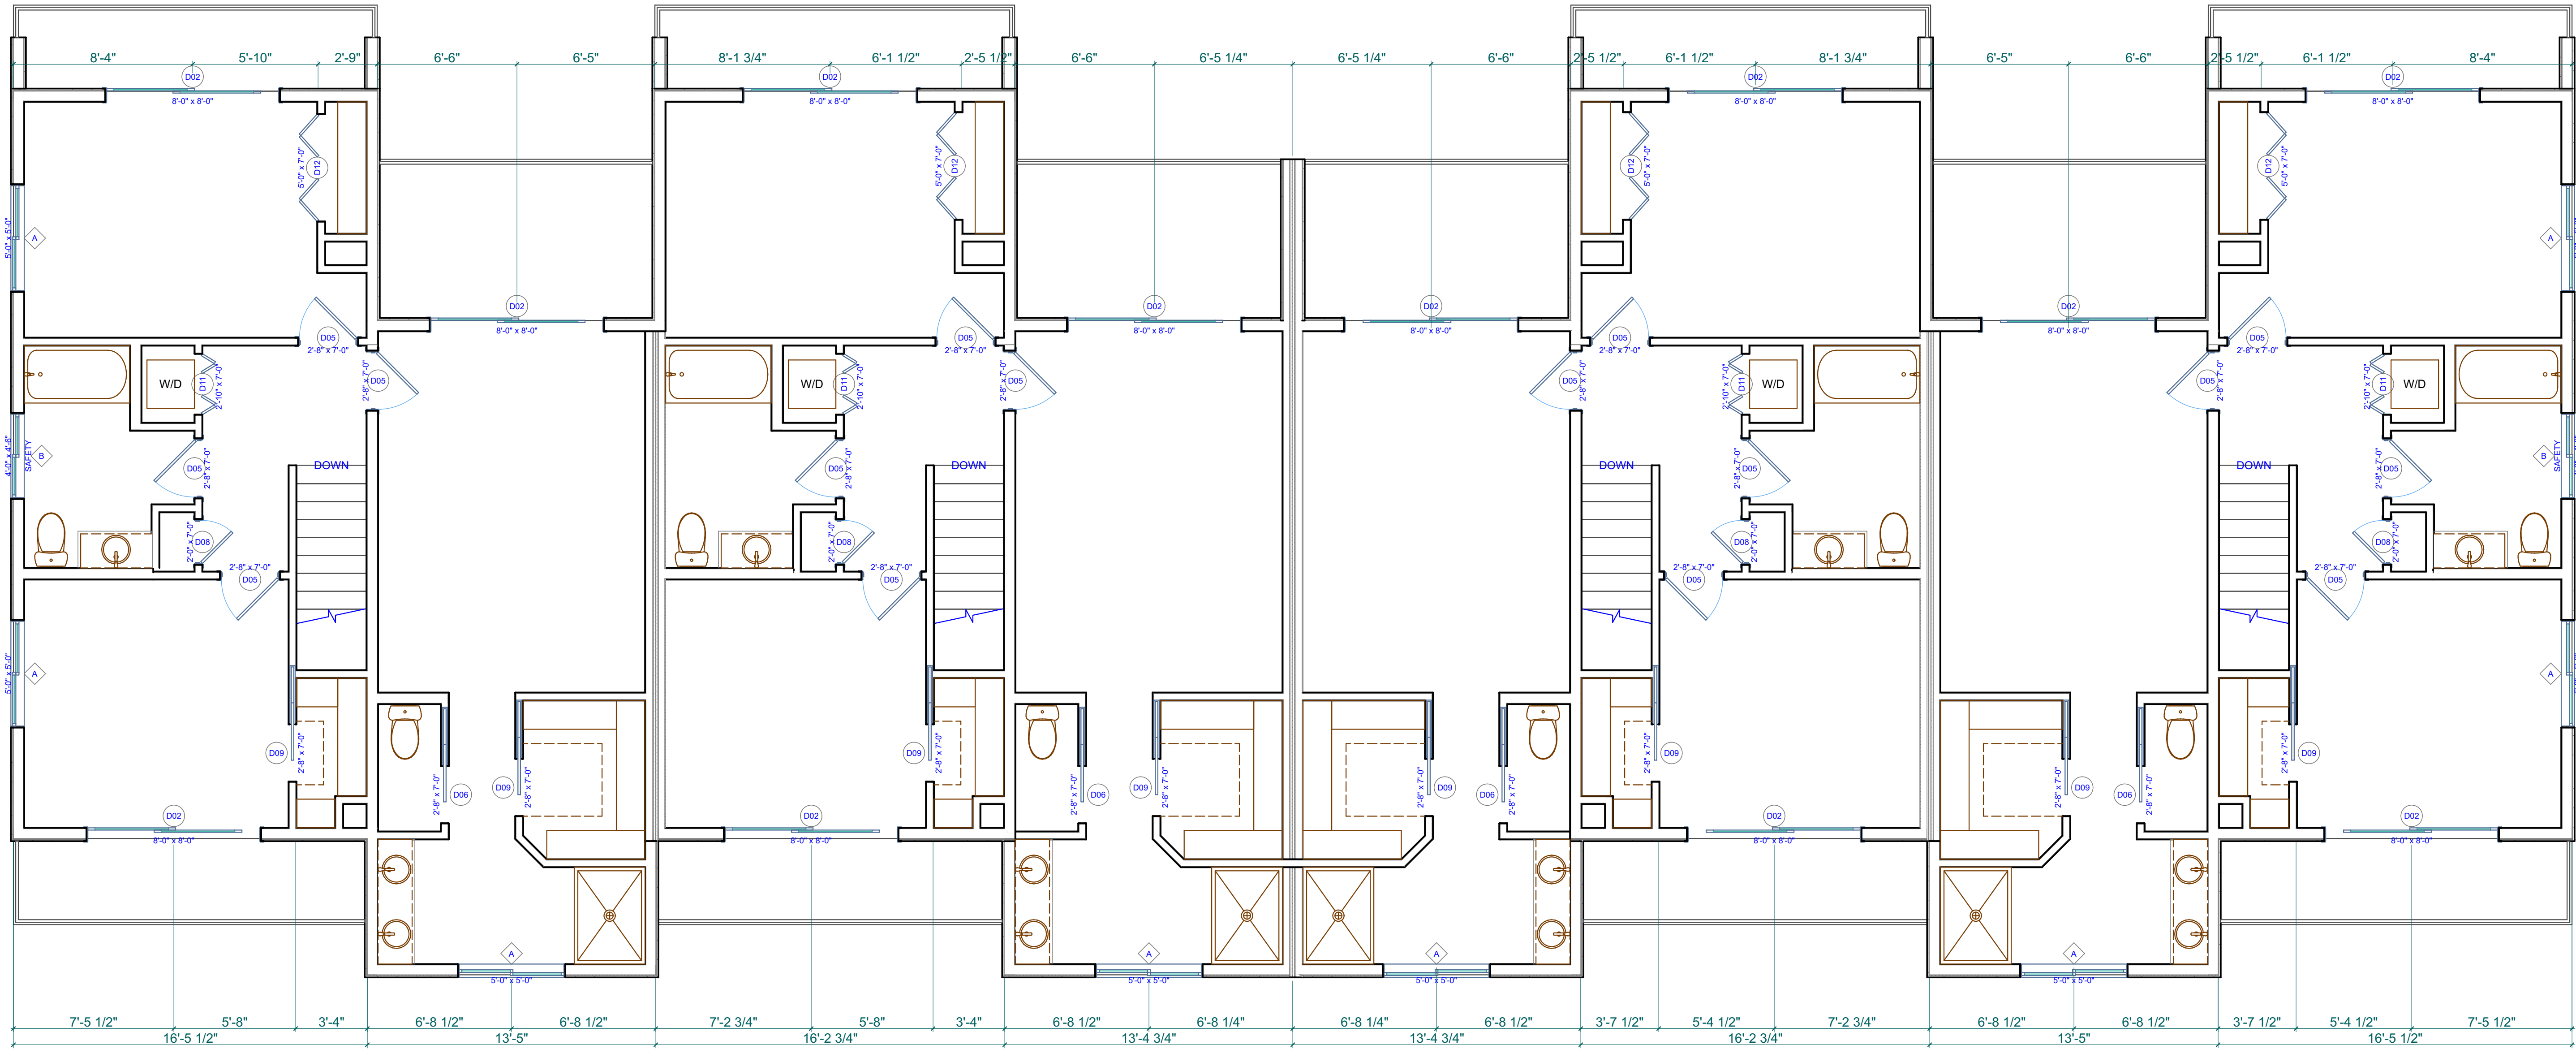

E1 Second Floor Plan
SCALE: 1/4" = 1'-0"

CLIENT:
Big Water Townhomes


PROJECT:
Plan -
Lake Powell,

MARK	DATE	DESCRIPTION


DATE: 1/5/2022
DRAWN BY:
PROJECT #:
PLAN ID:
SHEET NAME:

Floor Plan,
Second Floor

COPYRIGHT © 2022 . THESE DRAWINGS ARE INSTRUMENTS OF SERVICE ONLY AND REMAIN THE PROPERTY OF . REPRODUCTION, USE OR TRANSLATION THEREOF WITHOUT WRITTEN PERMISSION IS UNLAWFUL

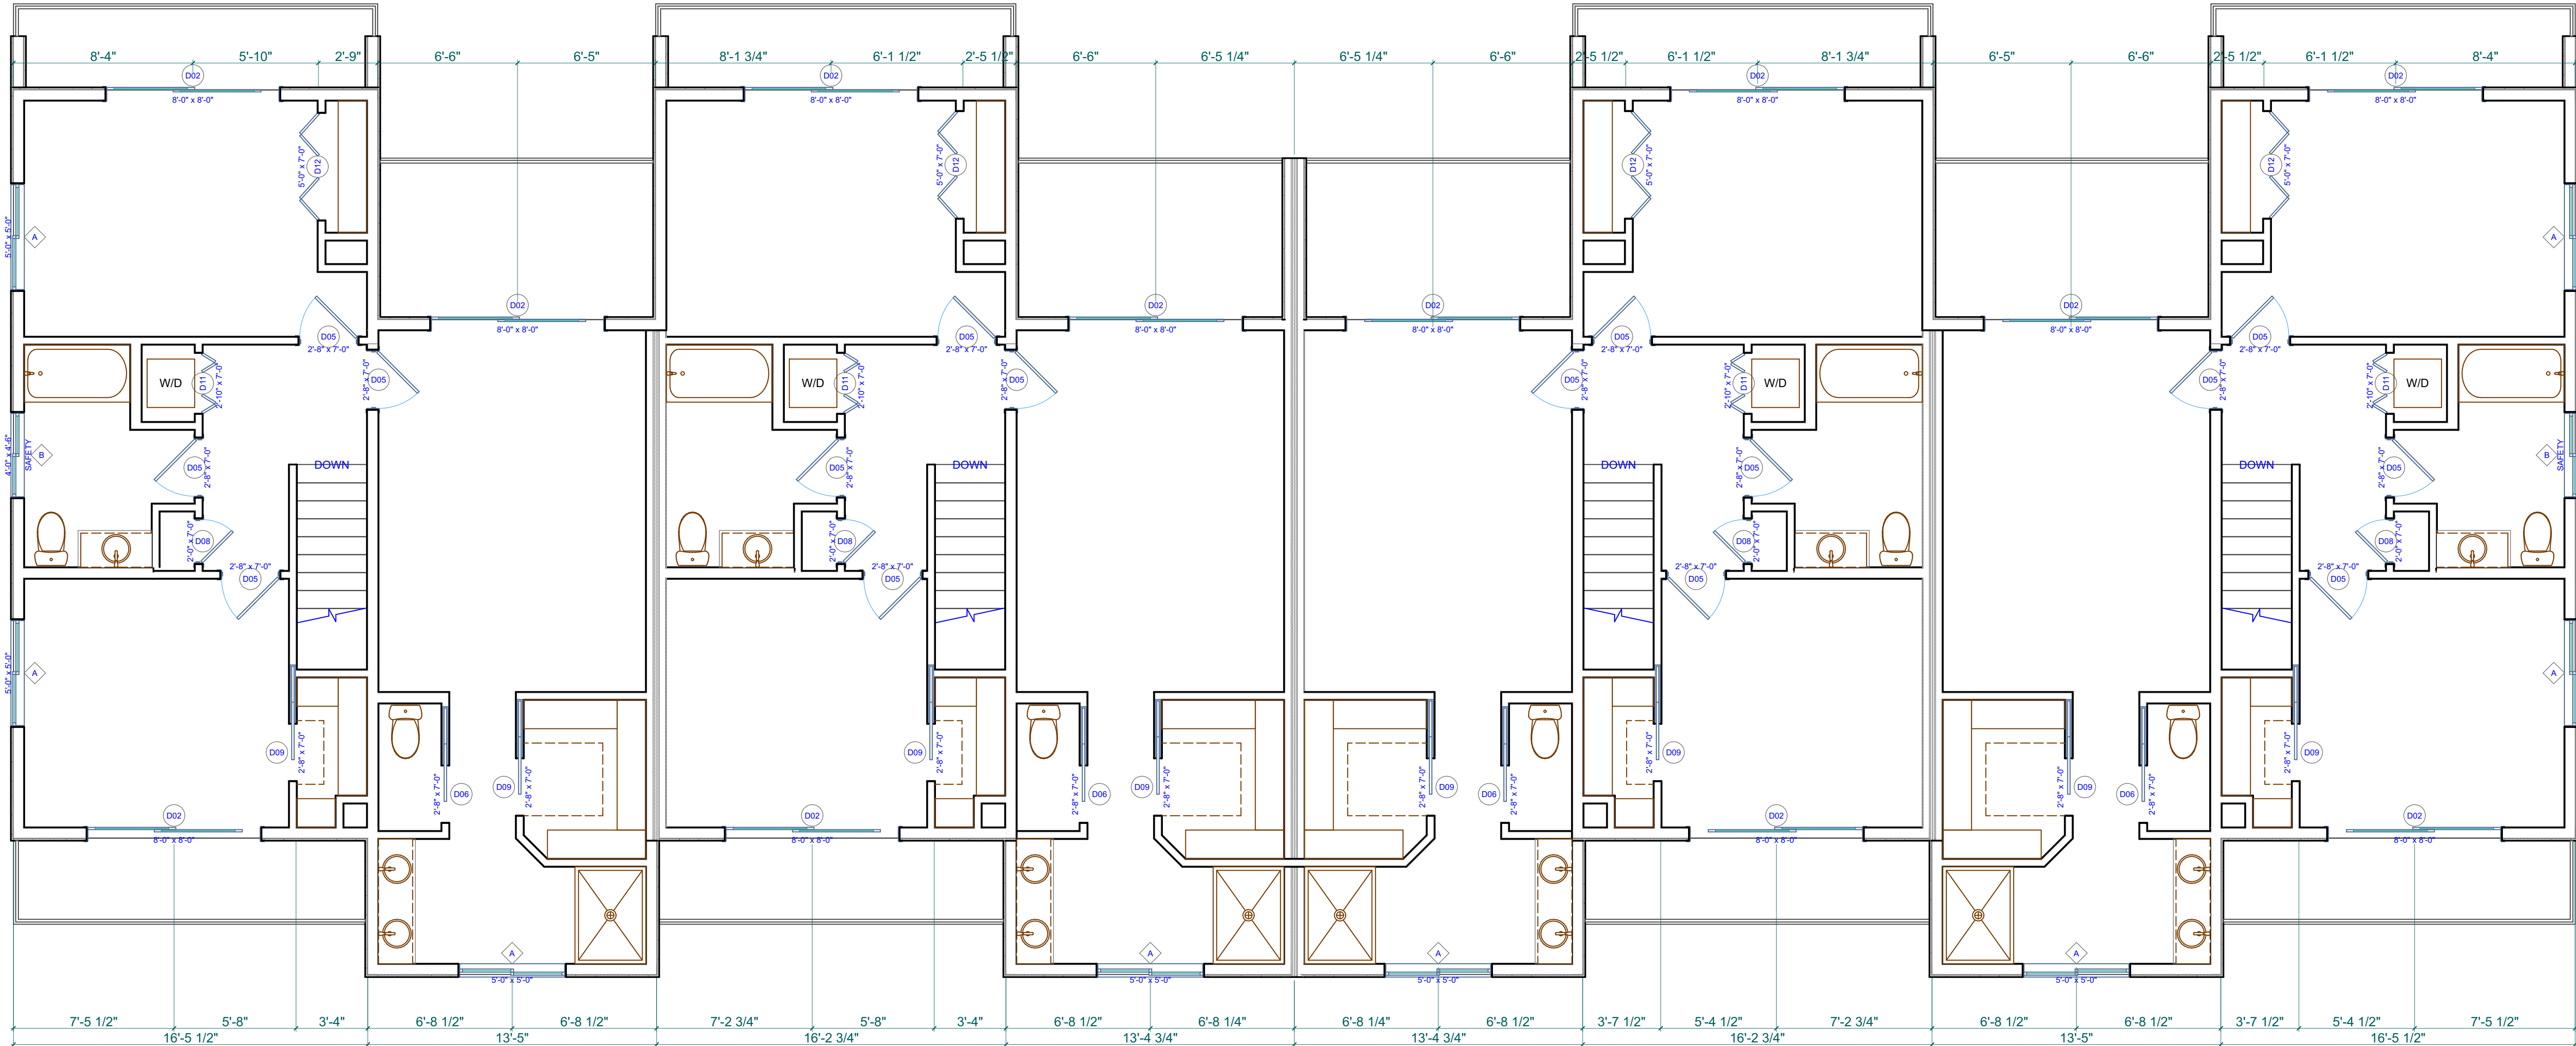

E1 Second Floor Plan
SCALE: 1/4" = 1'-0"

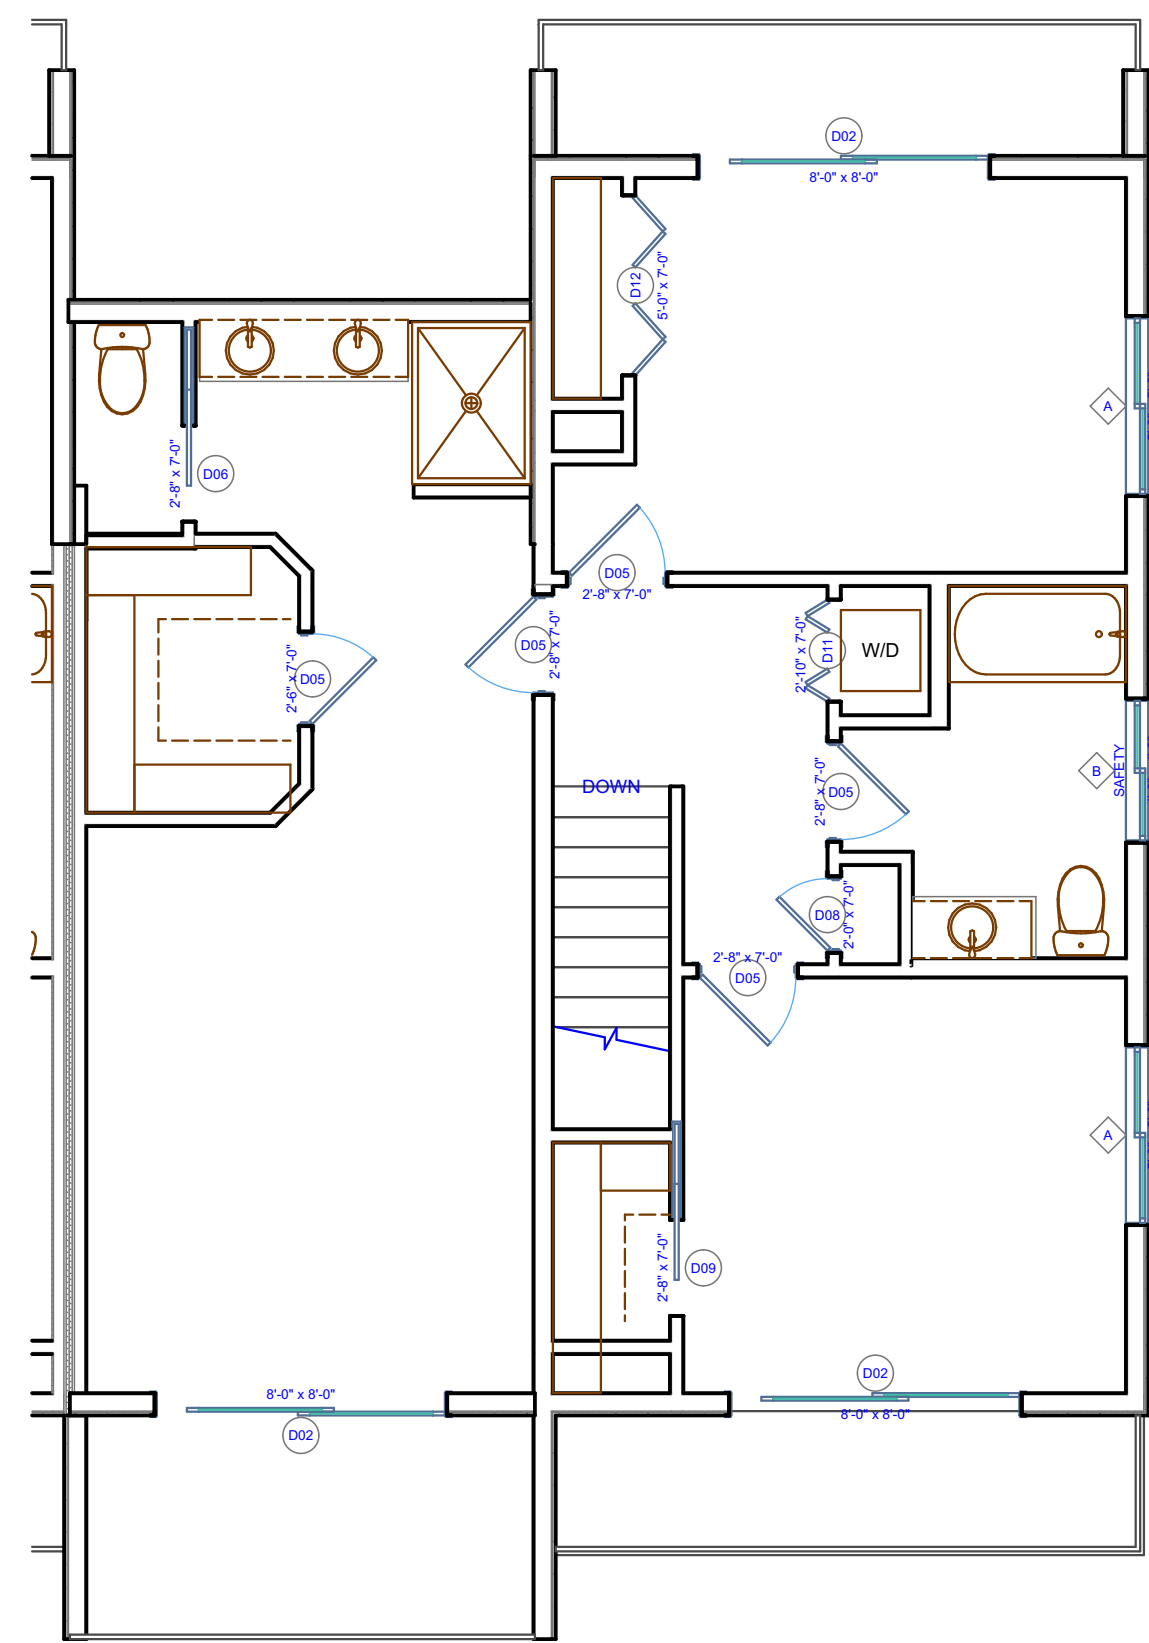

A12 Alternate Master Bedroom
SCALE: 3/16" = 1'-0"

CLIENT: **Big Water Townhomes**



PROJECT: **Plan - Lake Powell,**

MARK	DATE	DESCRIPTION

SHEET NAME:
**Floor Plan,
Second Floor**

ph. (702) 346-1174 fx. (702) 346-4252

COPYRIGHT © 2022 . THESE DRAWINGS ARE INSTRUMENTS OF SERVICE ONLY AND REMAIN THE PROPERTY OF . REPRODUCTION, USE OR TRANSLATION THEREOF WITHOUT WRITTEN PERMISSION IS UNLAWFUL

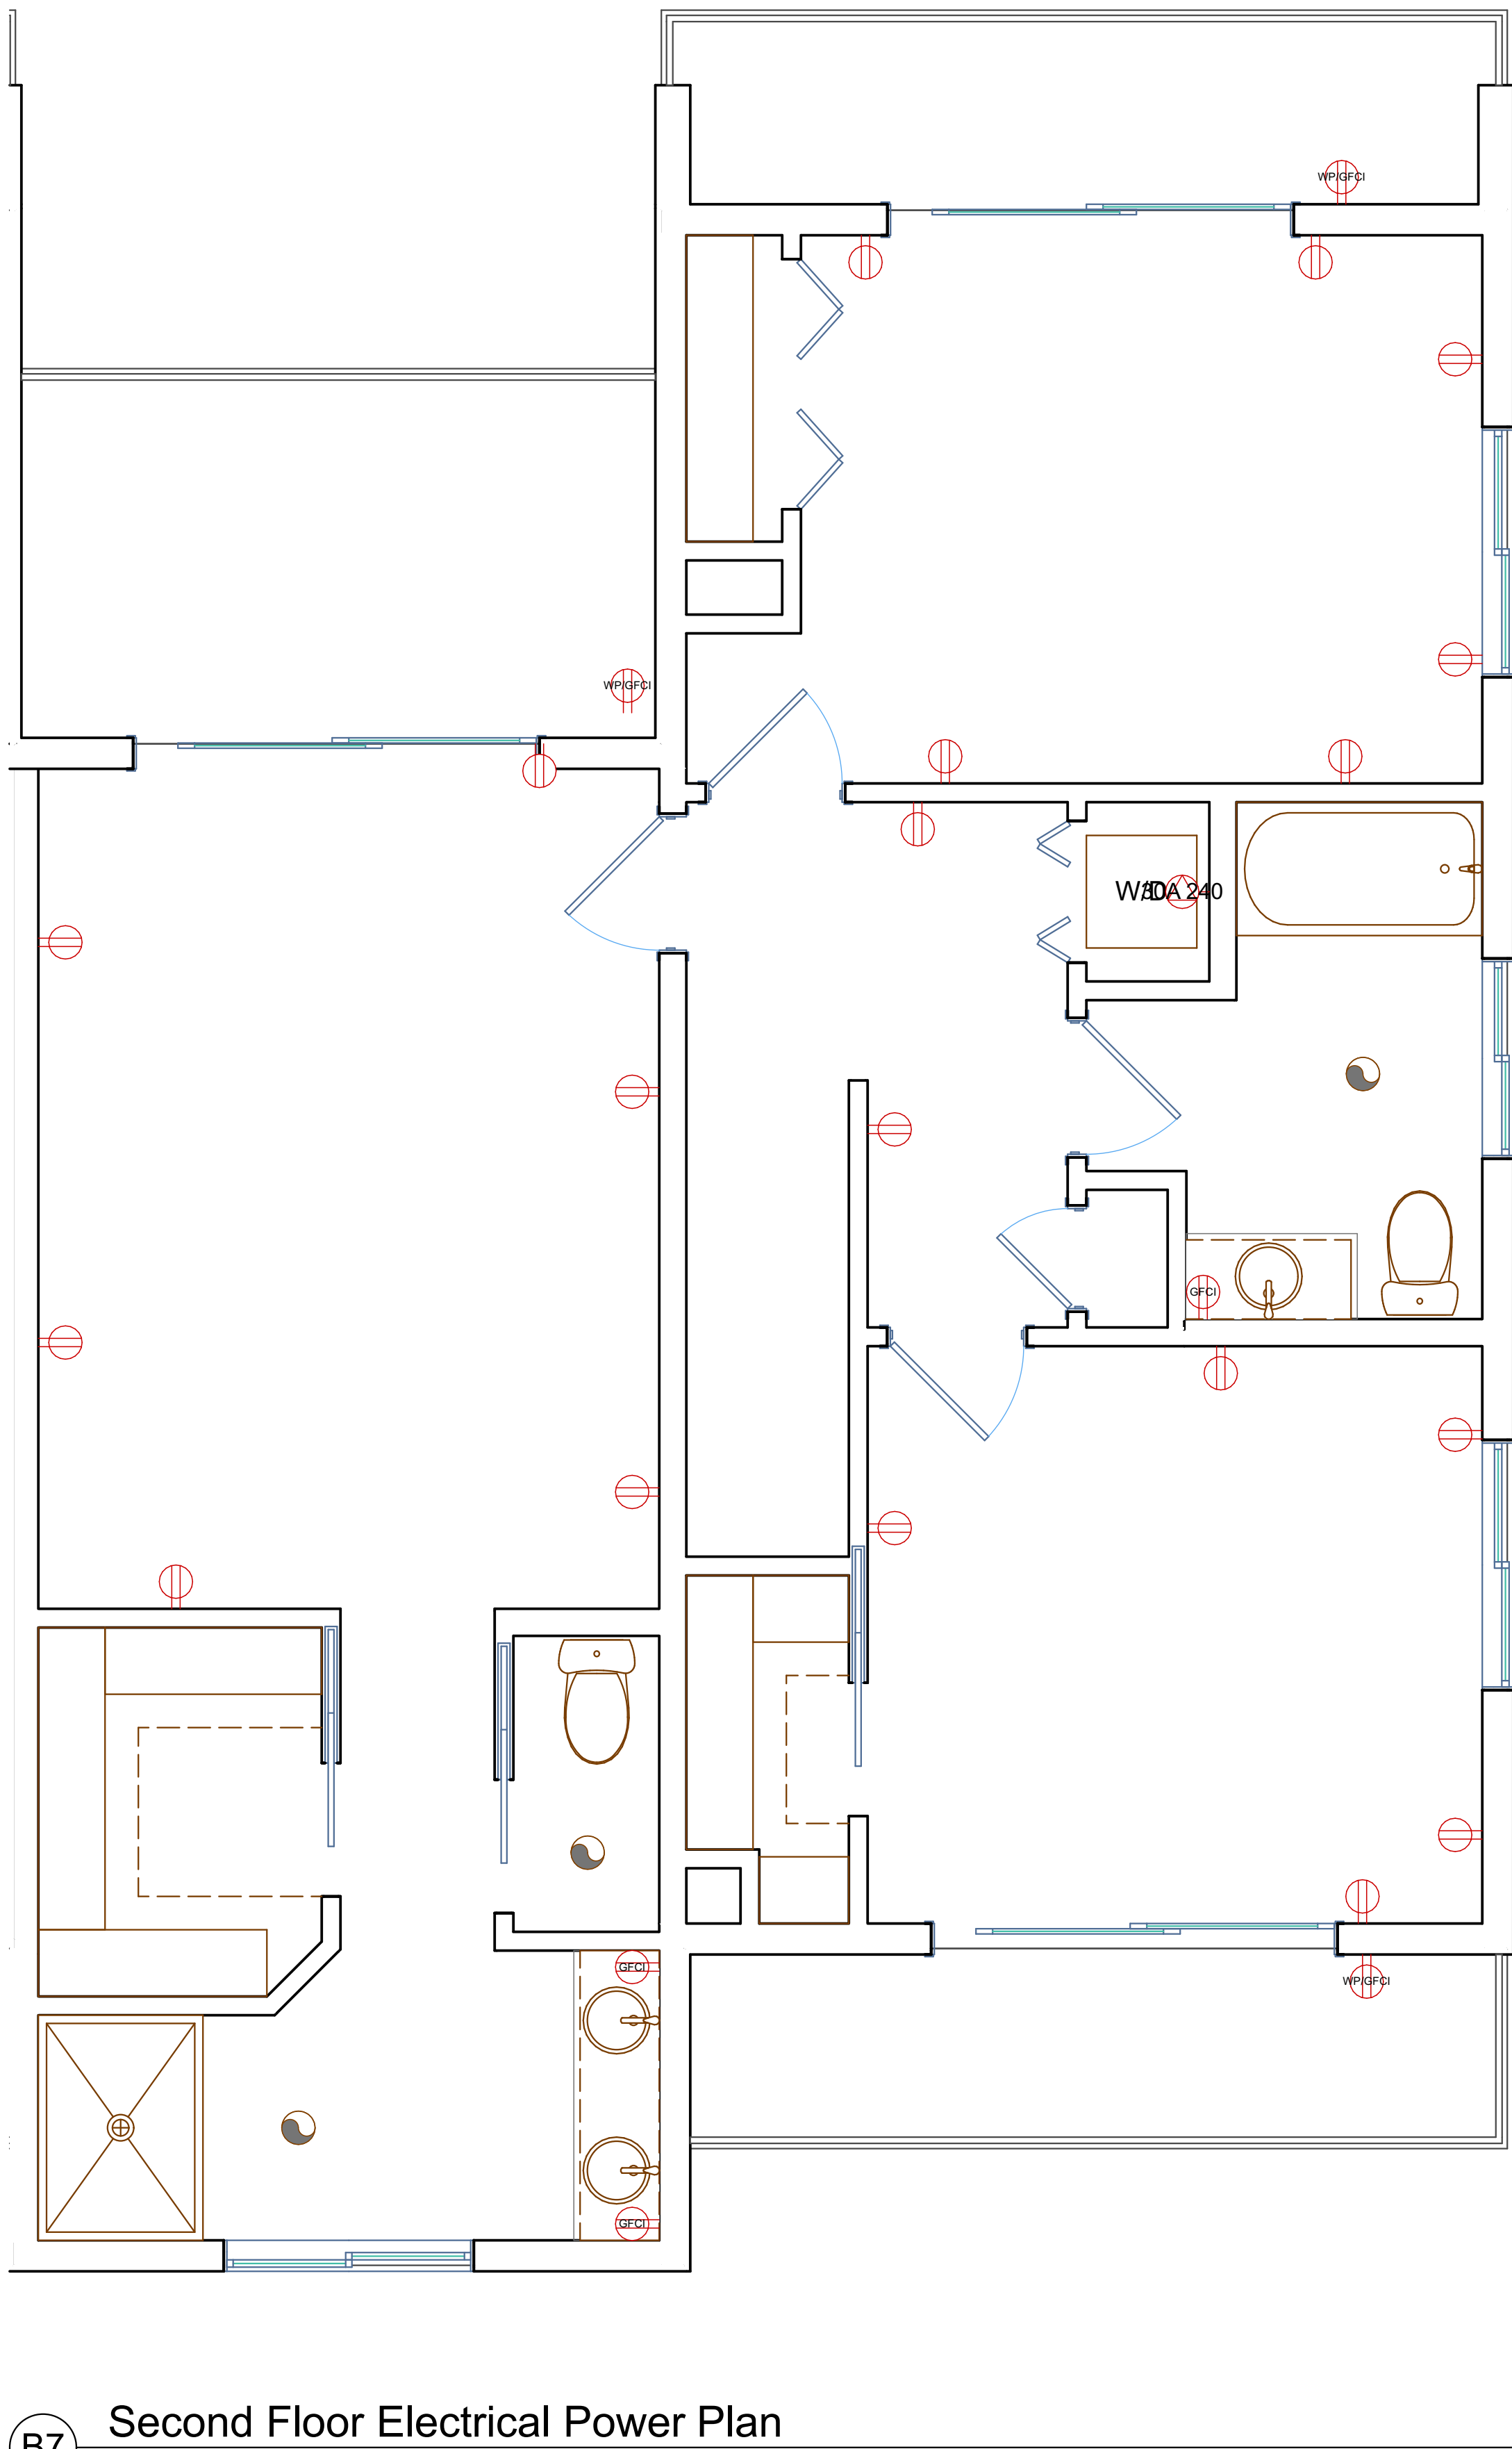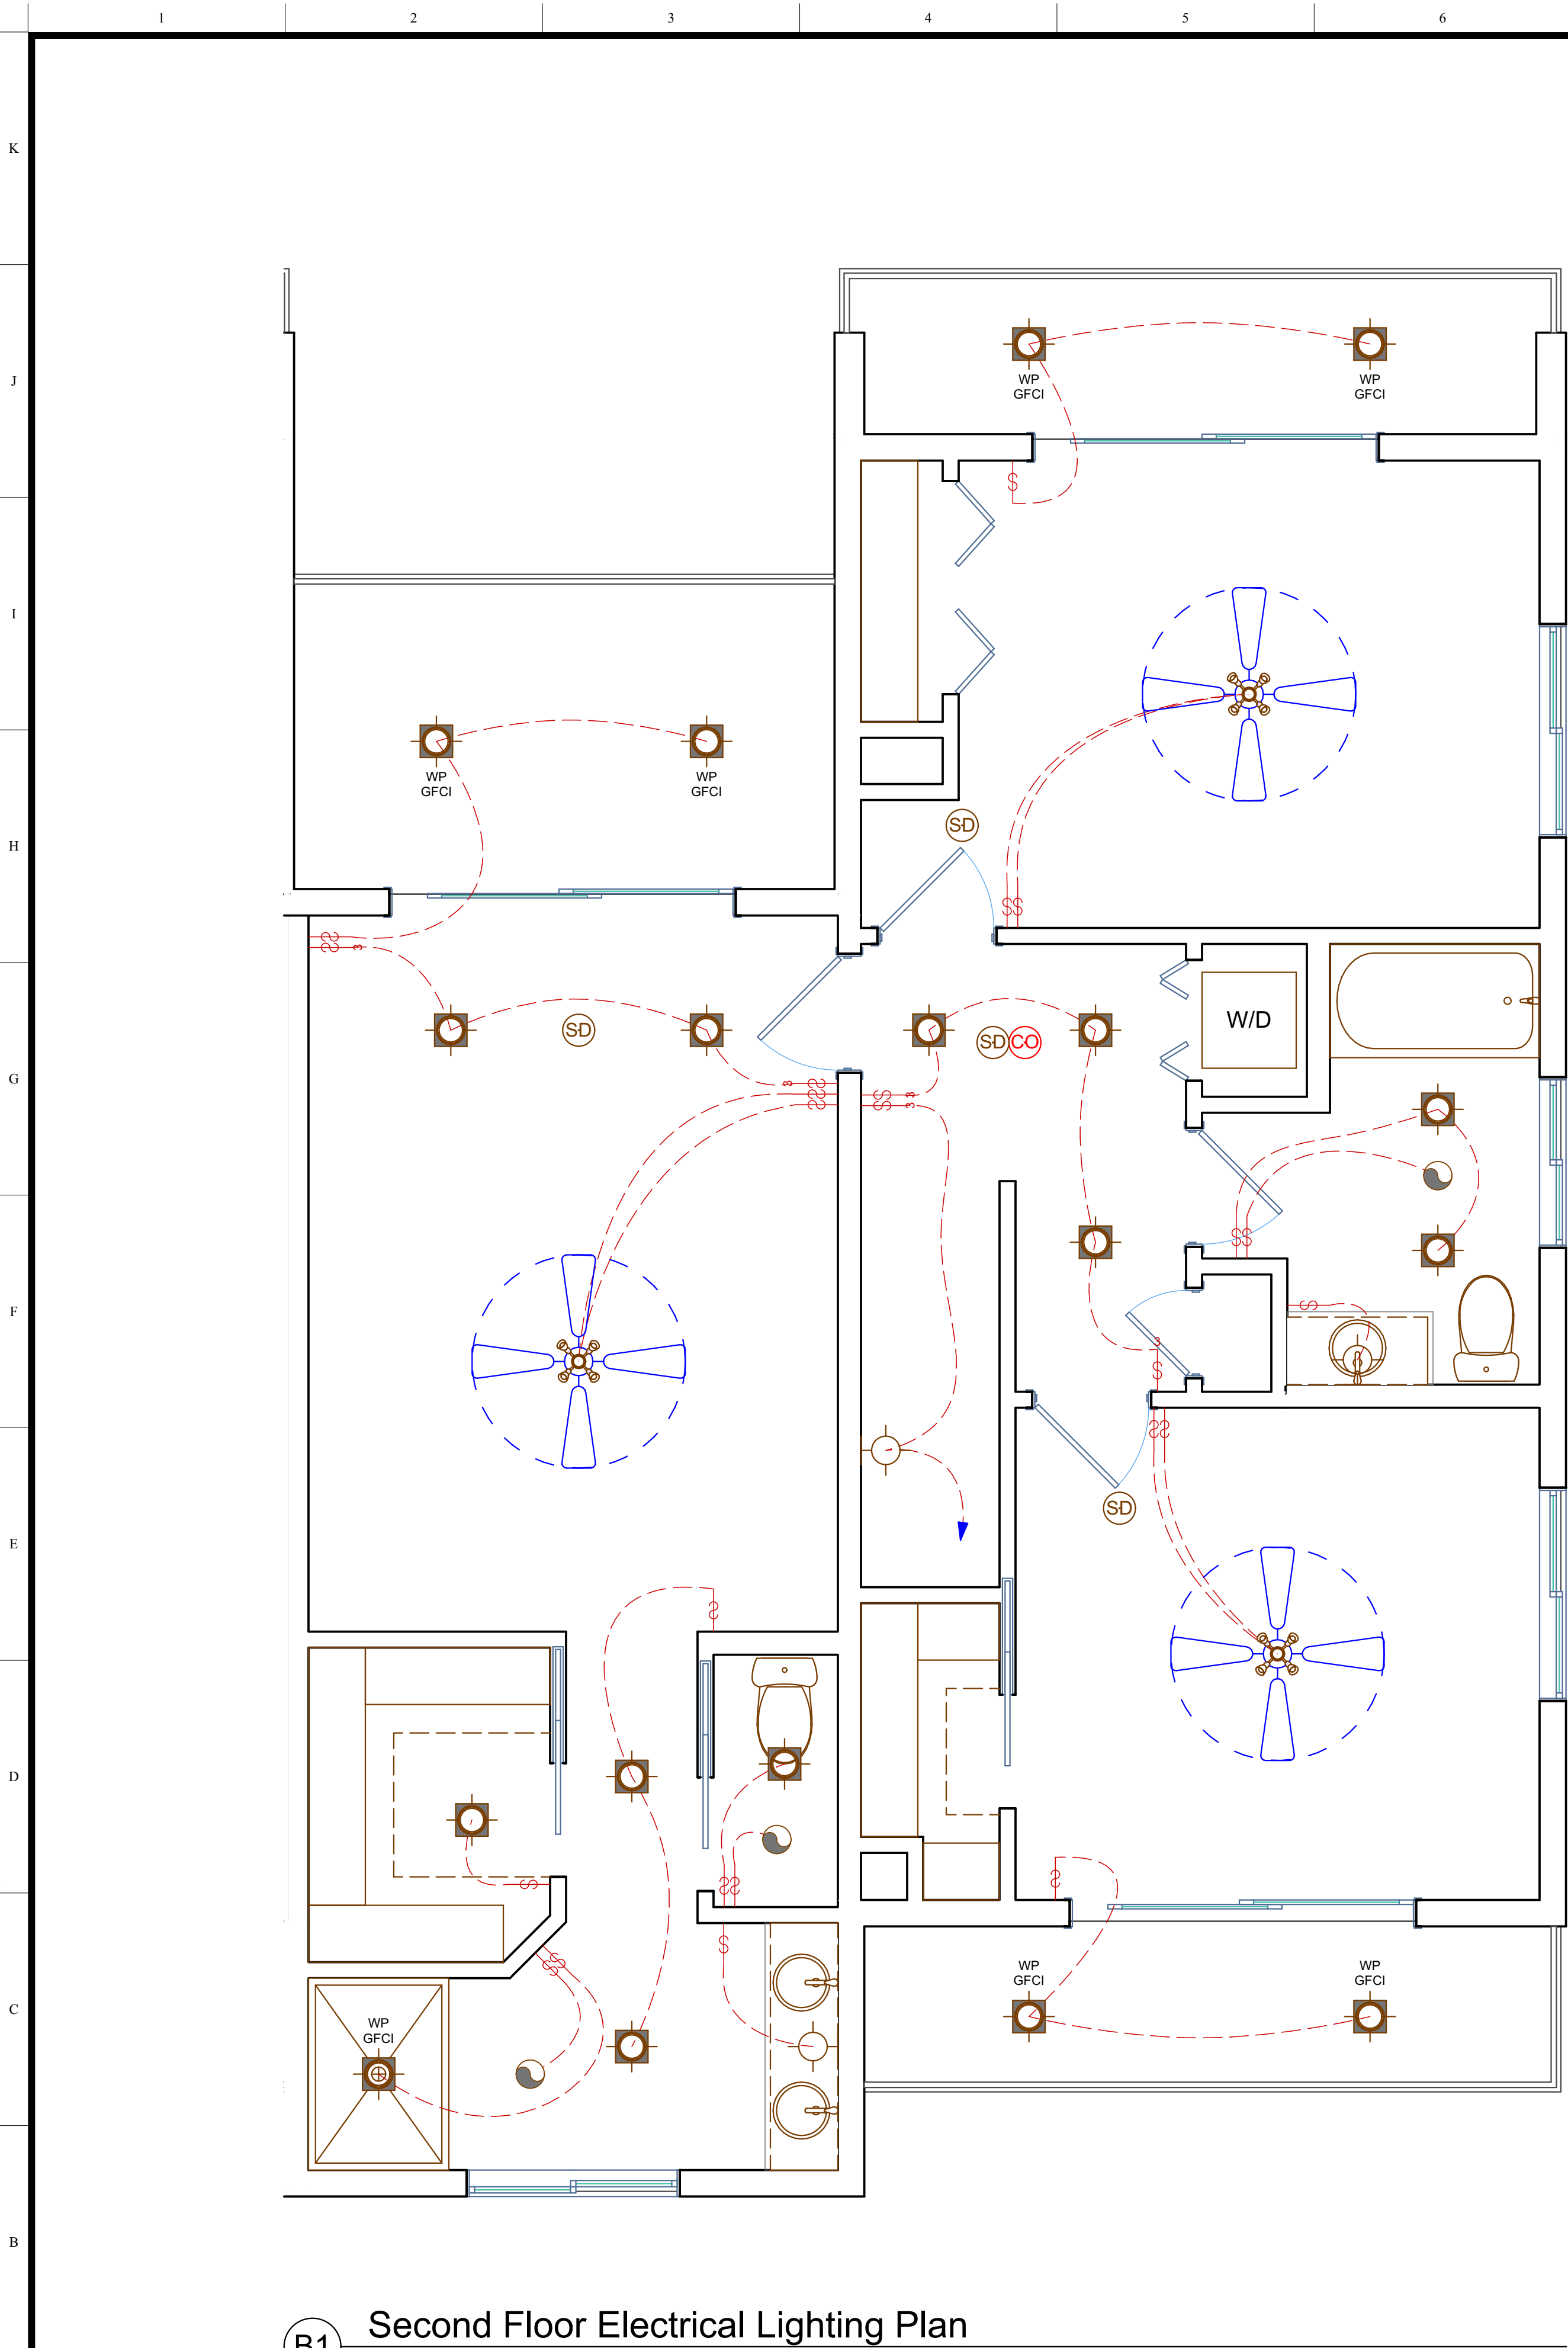

PROJECT: Big Water Townhomes		
CLIENT: Lake Powell, Plan		
ph. (702) 346-1174 fx. (702) 346-4252		
DATE: 1/5/2022		
DRAWN BY:		
PROJECT #:		
PLAN ID:		
SHEET NAME: Second Floor Electrical Plan		




SHEET NAME:
First Floor
Electrical Plan

PROJECT: Plan - Lake Powell,


ph. (702) 346-1174 fx. (702) 346-4252

COPYRIGHT © 2022. THESE DRAWINGS ARE INSTRUMENTS OF SERVICE ONLY AND REMAIN THE PROPERTY OF . REPRODUCTION, USE OR TRANSLATION THEREOF WITHOUT WRITTEN PERMISSION IS UNLAWFUL.

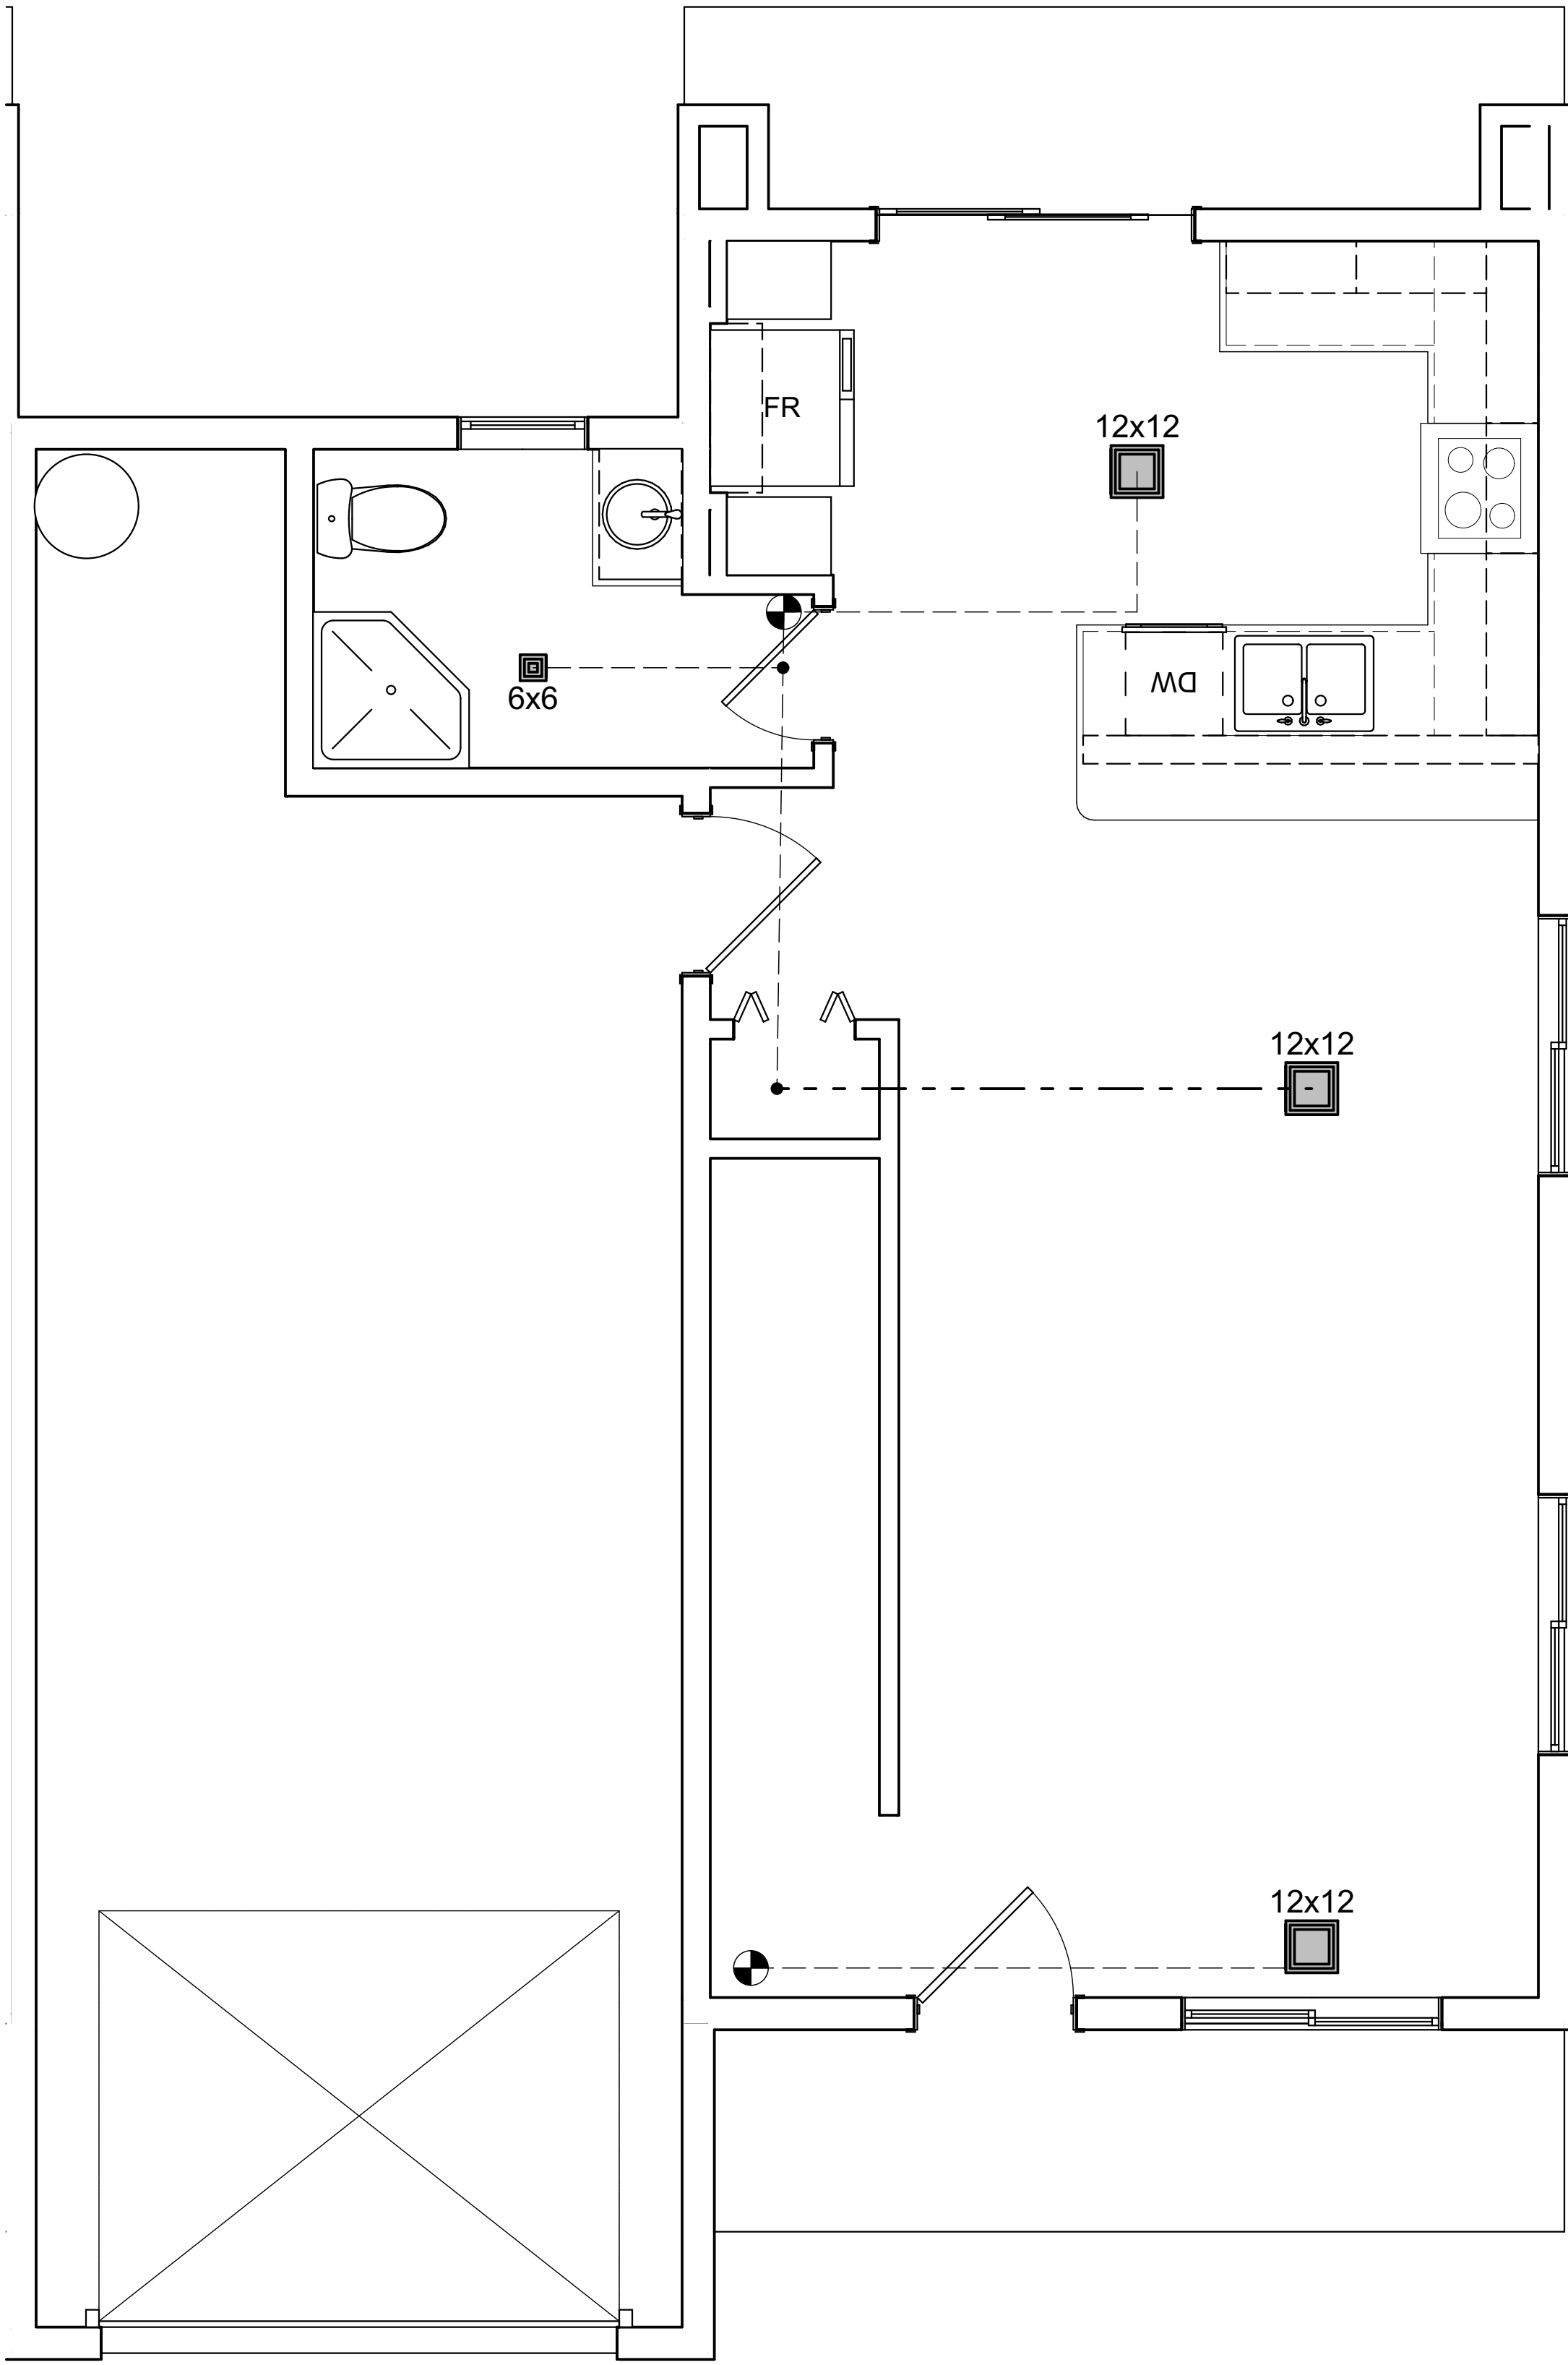

B1 Typical First Floor HVAC

SCALE: 3/8" = 1'-0"

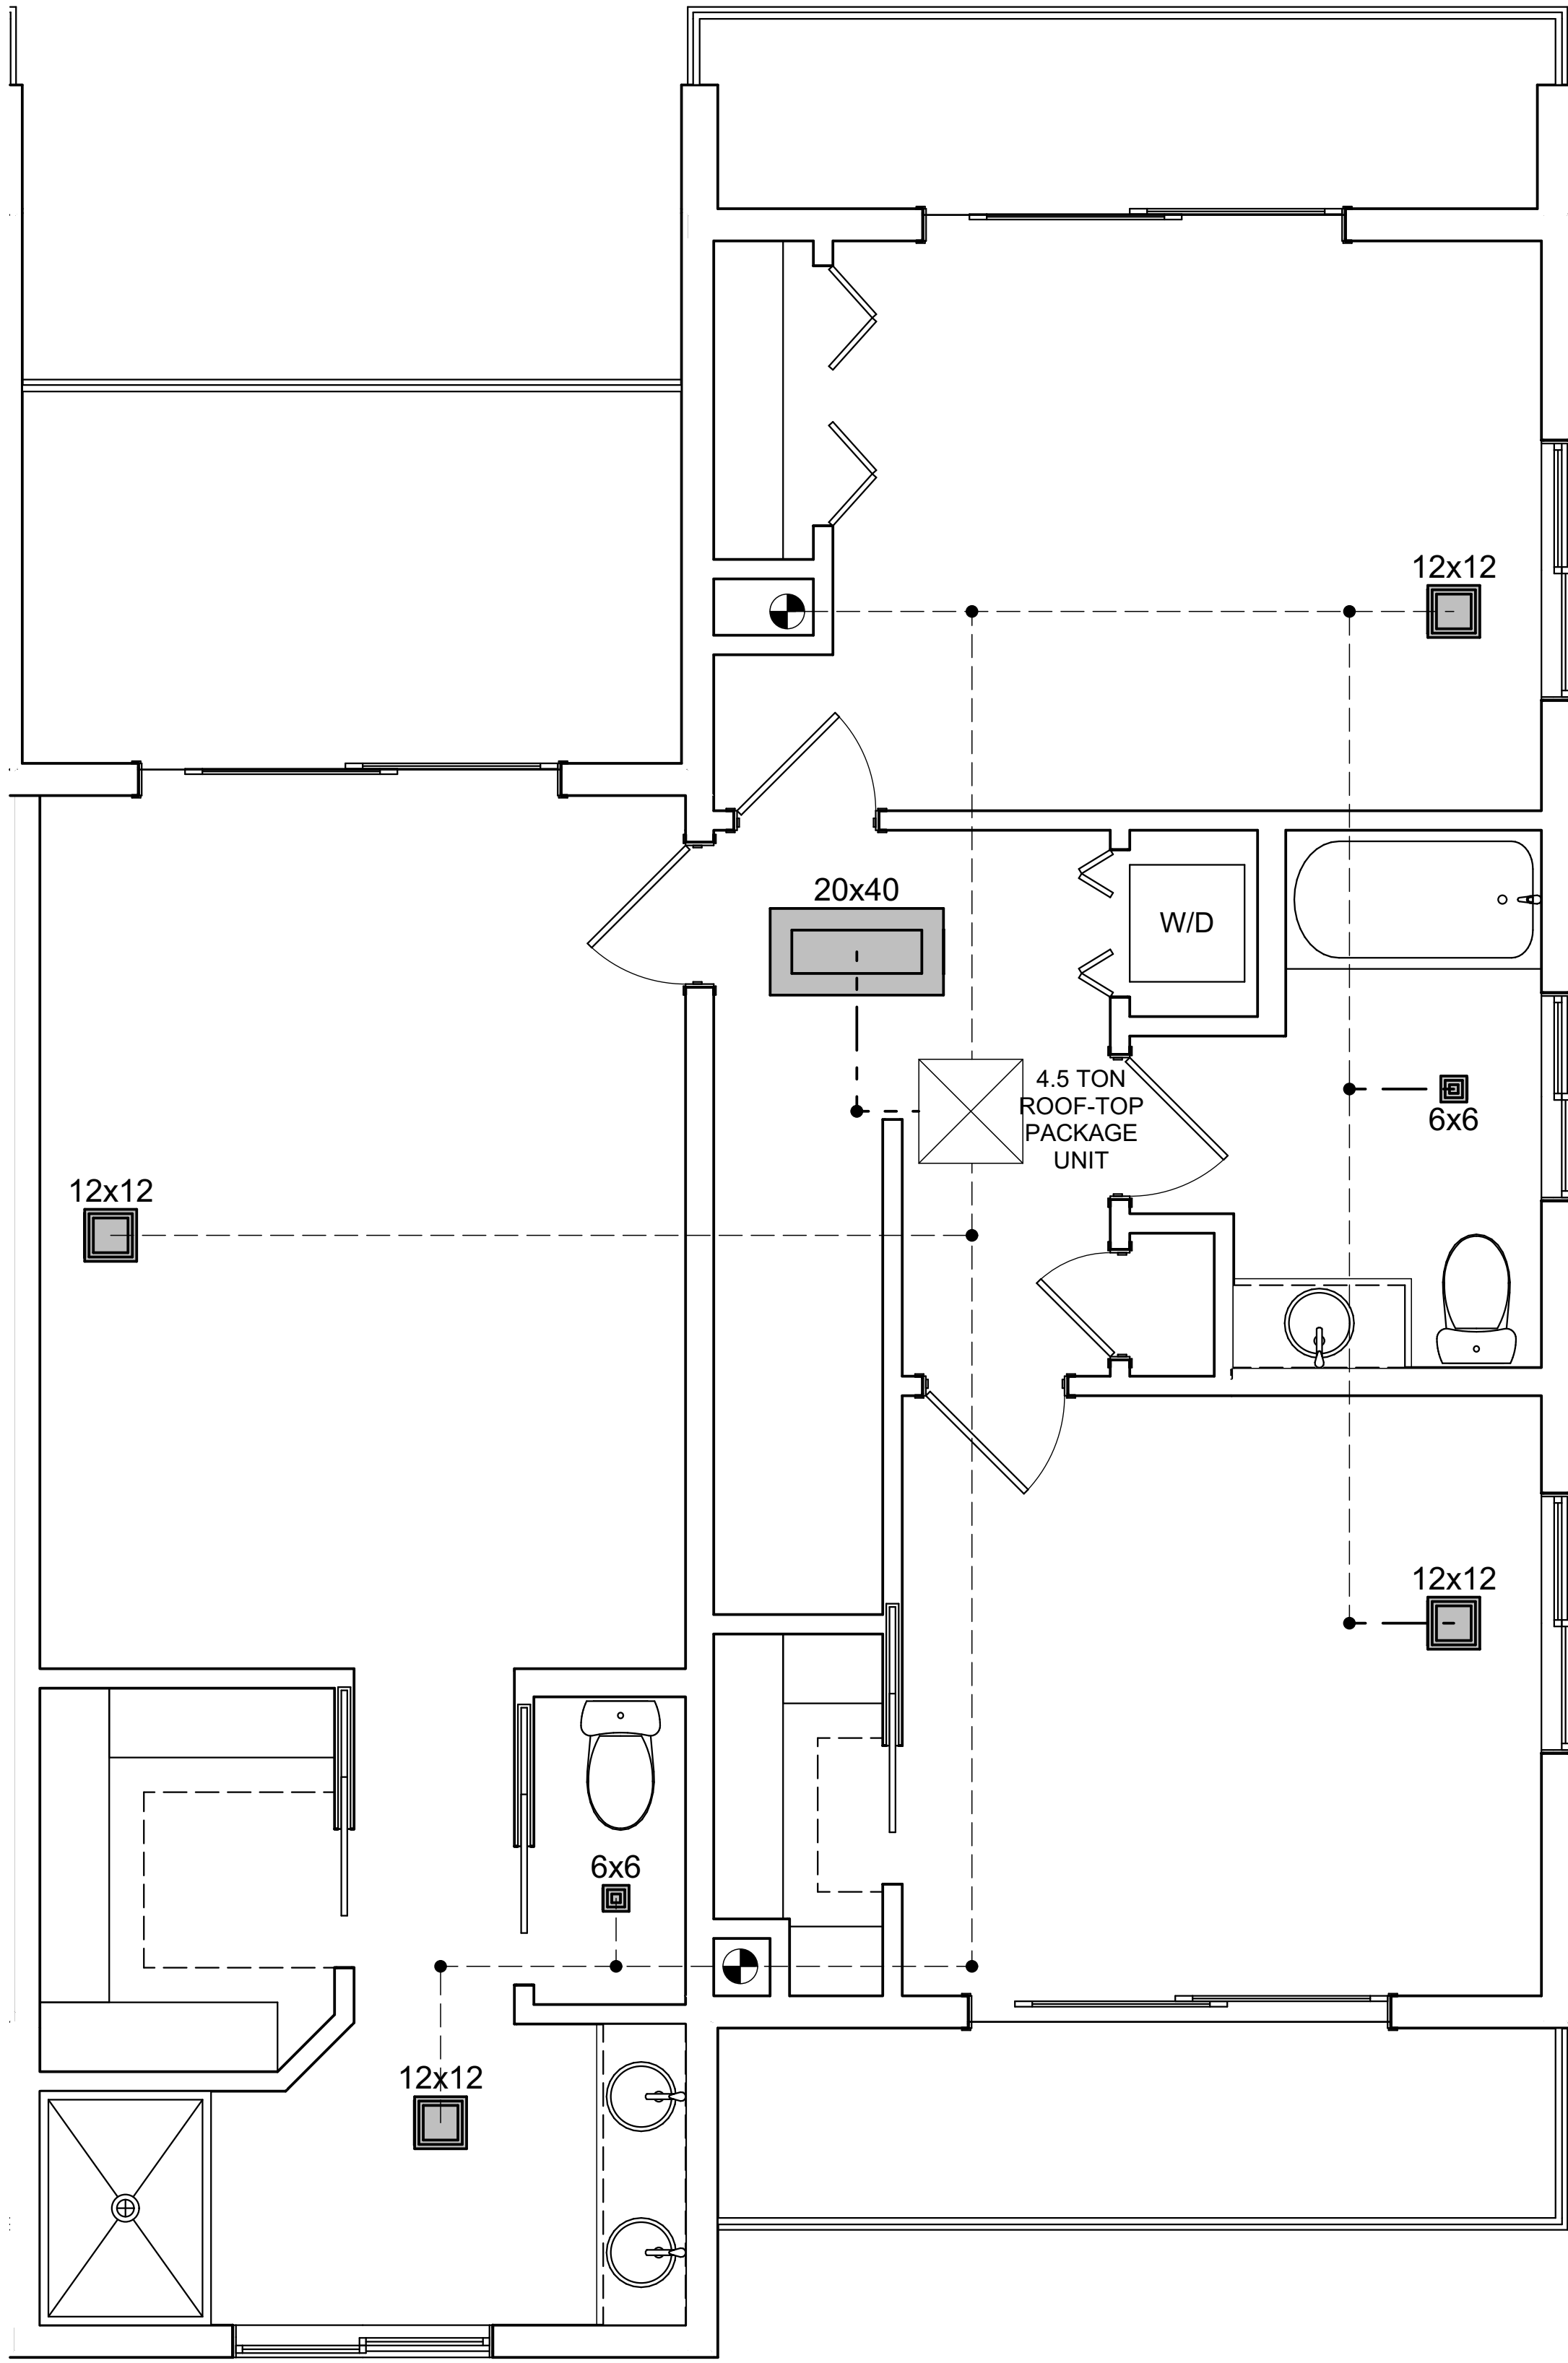

B7 Typical Second Floor HVAC

SCALE: 3/8" = 1'-0"

CLIENT: Big Water Townhomes

PROJECT: Plan - Lake Powell, I

MARK	DATE	DESCRIPTION
DATE:	1/5/2022	
DRAWN BY:		
PROJECT #:		
PLAN ID:		

SHEET NAME: HVAC Plan

ph. (702) 346-1174 fx. (702) 346-4252